

[illegible]

Co., Ltd

Construction Management

Tel : +66 (0) 5380 4671 Fax : +66 (0) 5380 4672
E-mail : axisgroup1994@gmail.com

Architect	working materials	9/26/15	Authorized Signature	
	client agreement	7/26/16/20	Authorized Signature	
	interior details	7/26/16/20	Authorized Signature	
	client feedback	7/26/16/20	Authorized Signature	
Interior Designer	interior design	7/26/17/20	Authorized Signature	
Structural Engineer	structural analysis	8/1/2015	Authorized Signature	
	structural design	7/26/2012	Authorized Signature	
	structural details	7/26/2012	Authorized Signature	
	structural materials	7/26/2012	Authorized Signature	
Electrical Engineer	electrical load	9/26/16/20	Authorized Signature	
	electrical design	7/26/16/20	Authorized Signature	
	electrical materials	7/26/16/20	Authorized Signature	
	electrical details	7/26/16/20	Authorized Signature	
Sanitary Engineer	sanitary design	7/26/20	Authorized Signature	
	sanitary materials	7/26/20	Authorized Signature	
	sanitary details	7/26/20	Authorized Signature	
	sanitary design	7/26/20	Authorized Signature	
Mechanical Engineer	mechanical design	8/1/2015	Authorized Signature	
	mechanical materials	7/26/2012	Authorized Signature	
	mechanical details	7/26/2012	Authorized Signature	
	mechanical design	7/26/2012	Authorized Signature	
Interior Design	interior design	7/26/2012	Authorized Signature	
	interior materials	7/26/2012	Authorized Signature	
	interior details	7/26/2012	Authorized Signature	
	interior design	7/26/2012	Authorized Signature	
Landscape Design	landscape design	7/26/2012	Authorized Signature	
	landscape materials	7/26/2012	Authorized Signature	
	landscape details	7/26/2012	Authorized Signature	
	landscape design	7/26/2012	Authorized Signature	
Drawn by	drawn by	7/26/2012	Authorized Signature	
	drawn by	7/26/2012	Authorized Signature	
	drawn by	7/26/2012	Authorized Signature	
	drawn by	7/26/2012	Authorized Signature	
Printed Date	printed date	7/26/2012	Authorized Signature	
	printed date	7/26/2012	Authorized Signature	
	printed date	7/26/2012	Authorized Signature	
	printed date	7/26/2012	Authorized Signature	
Ref. File	ref. file	7/26/2012	Authorized Signature	
	ref. file	7/26/2012	Authorized Signature	
	ref. file	7/26/2012	Authorized Signature	
	ref. file	7/26/2012	Authorized Signature	

Project Name

www.nfa.gov

Planning
Architectural Design
Project Consultant
Construction Management

300/27-28 Moo 1, Tambol Maheua, Muang, Chiangmai 50100 Thailand
Tel: +66 (0) 5380 4671 Fax: +66 (0) 5380 4672
E-mail: asigroup1994@gmail.com

Architectural floor plan of a building, likely a school or institutional structure, featuring a grid system (A-M, 1-16). The plan shows a large rectangular building with a central corridor and several rooms. A curved road or driveway is on the left side. The plan includes dimensions, room numbers, and a north arrow. A legend at the bottom left indicates 'STRONG FLOOR CONCRETE' and 'FLOOR FINISH'.

Legend:

- STRONG FLOOR CONCRETE
- FLOOR FINISH

Scale: 1:1000

North Arrow: N

Room Numbers: 1, 2, 3, 4, 5, 6, 7, 8, 9, 10, 11, 12, 13, 14, 15, 16

Dimensions: 1.00, 1.50, 2.00, 250.00, 250

[illegible]

300/27-28 Moo 1, Tambol Maheua, Muang, Chiangmai 50100 Thailand
Tel: +66 (0) 5380 4671 Fax: +66 (0) 5380 4672
E-mail: ext@cam.ac.th or cam@cam.ac.th

Architect	Authorized Signature	
Senior Architect	Authorized Signature	
Junior Architect	Authorized Signature	
Architectural Assistant	Authorized Signature	
Structural Engineer	Authorized Signature	
Electrical Engineer	Authorized Signature	
Mechanical Engineer	Authorized Signature	
Sanitary Engineer	Authorized Signature	
Landscaping Designer	Authorized Signature	
Drawn By	Authorized Signature	
Printed Date	Drawing No.	A-102 /29
Ref. File	Date	

சுருத்திப்பெயர்

Project Name

© 2006 Blackwell Publishing Ltd

Drawing Title

เพลงที่เรานำมาเสนอ

Issue/Revision	
Description	Date

[illegible]

Axiggroup
Co.,Ltd.

**Planning
Architectural Design
Project Consultant
Construction Management**

300/27-28 Moo 1, Tambol Maehua, Muang, Chiangmai 50100 Thailand
Tel: +66 (0) 5380 4671 Fax: +66 (0) 5380 4672
E-mail: axiscgroup1994@gmail.com

Architect	John Smith	06/15/2024	Authorized Signature
Architect	John Smith	06/15/2024	Authorized Signature
Structural Engineer	John Smith	06/15/2024	Authorized Signature
Electrical Engineer	John Smith	06/15/2024	Authorized Signature
Mechanical Engineer	John Smith	06/15/2024	Authorized Signature
Interior Design	John Smith	06/15/2024	Authorized Signature
Landscape Design	John Smith	06/15/2024	Authorized Signature
Drawn By	John Smith	06/15/2024	Authorized Signature
Printed Date	06/15/2024	06/15/2024	Authorized Signature
Ref. File	A-108 / 29	Date	

Project Name

Issue/Revision

Co., Ltd

Construction Management

E-mail: axiscgroup1994@gmail.com

Architect	Authorized Signature
archim@archim. 417-813-0022 1000 Locust St. #200 St. Louis, MO 63103 770-177-0228	 David J. Brown

Structure Engineer	Authorized Signatures
Fachbereich BauT	
Hr. Dr. H.	
als Sachverständiger	09.07.2012
Electrical Engineer	Authorized Signatures
Technische Hilfe	
Herrn Dr. H.	
Projektschaffung	09.07.2012

Santry Engineer	Authorized Signature
4/26/2016 08:31:41 AM	
78.73	

Mechanical Engineer		Authorized Signature	
3/3/2017 12:00PM	EN 334.0		
01/04/2017 09:01	EN 15623		
02/07/2017 10:00	EN 33667		

	Authorized Signature
Interior Design	

Landscape Design	Authorized Signature
W771116 11/18	<i>[Signature]</i>
P21711 3/15	

Drawn By	Authorized Signature
<i>Pratik Srivastava</i>	<i>Pratik</i>

Printed Data	Drawing No.
	A-106 /29

[illegible]

Owner

30207 2018 Map 1

Project Name

30207 2018 Map 1

Drawing Title	
30207 2018 Map 1	
Issue/Revision	Date
Description	

Axisgroup

Planning
 Architectural Design
 Project Consultant
 Construction Management

30207 2018 Map 1

30207 2018 Map 1

 

 

30207 2018 Map 1

30207 2018 Map 1

30207 2018 Map 1

30207 2018 Map 1

Architect	Axisgroup
Architectural Design	Axisgroup
Project Consultant	Axisgroup
Construction Management	Axisgroup
Structural Engineer	Axisgroup
Electrical Engineer	Axisgroup
Mechanical Engineer	Axisgroup
Sanitary Engineer	Axisgroup
Interior Design	Axisgroup
Landscape Design	Axisgroup
Ref. File	Date

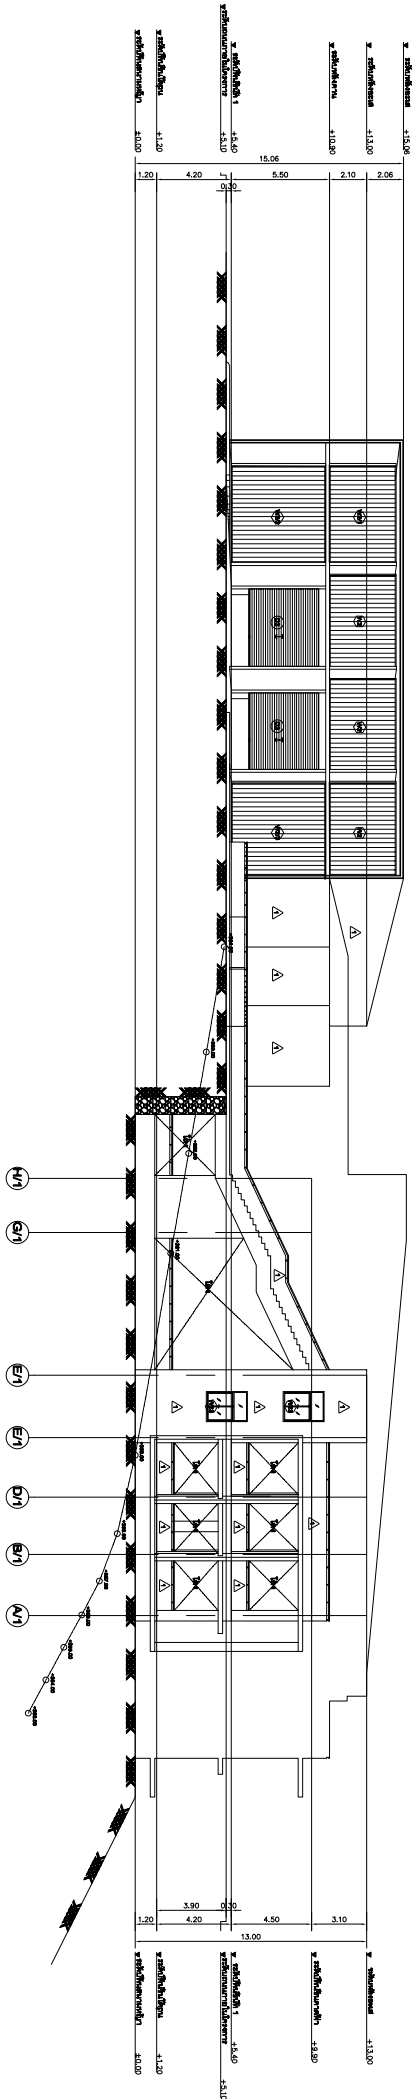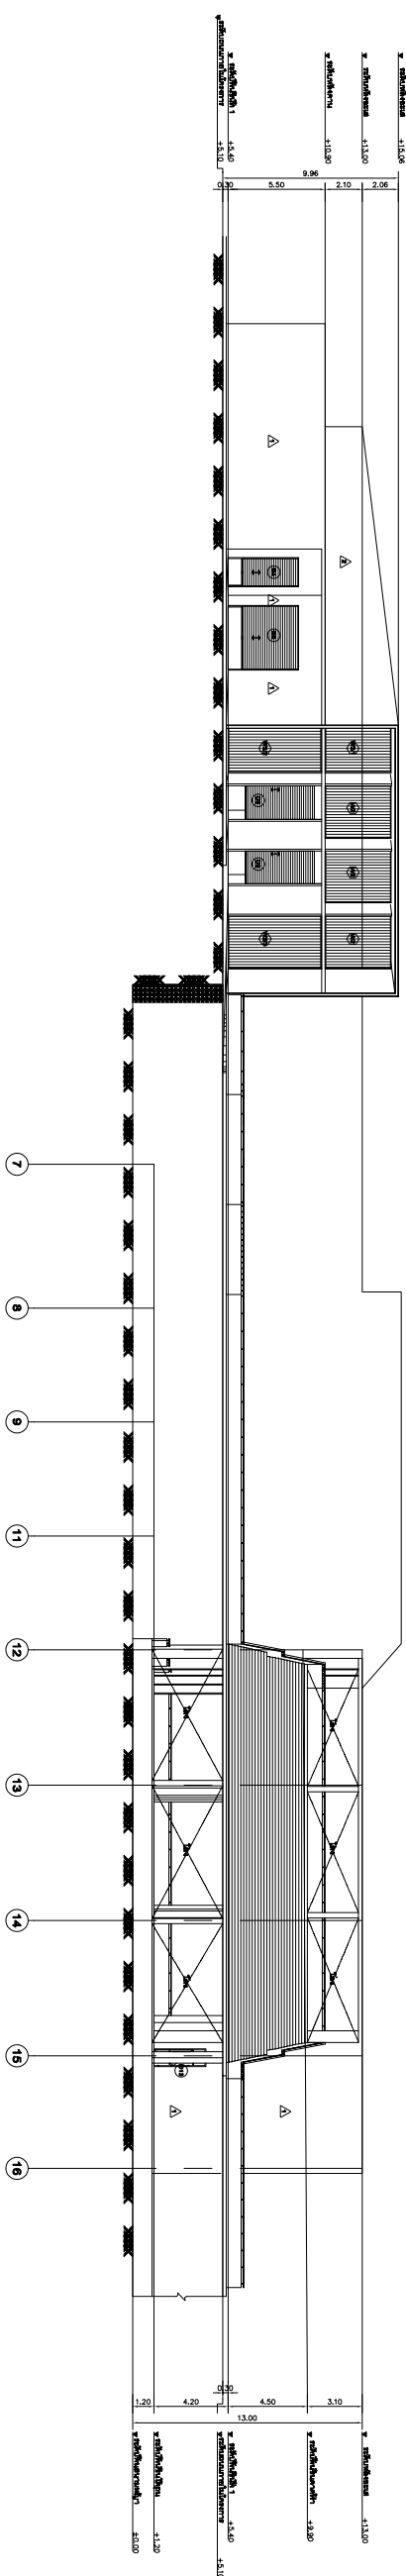

Drawn By	Axisgroup
Printed Date	A-201 /29
Ref. File	Date

OWNER

30072-2018-0001

Project Name

30072-2018-0001

Drawing Title

30072-2018-0001

Issue/Revision	Description	Date

Axisgroup

Planning
 Architectural Design
 Project Consultant
 Construction Management

30072-2018-0001 1. Technical Drawing - Main Drawing 30072-2018-0001
 30072-2018-0001 1. Technical Drawing - Main Drawing 30072-2018-0001
 30072-2018-0001 1. Technical Drawing - Main Drawing 30072-2018-0001

Architect	Author	Signature

Structural Engineer	Author	Signature

Electrical Engineer	Author	Signature

Sanitary Engineer	Author	Signature

Mechanical Engineer	Author	Signature


Interior Design	Author	Signature

Landscape Design	Author	Signature


Drawn By	Author	Signature

Printed Date	Drawing No.

Ref. File	Date

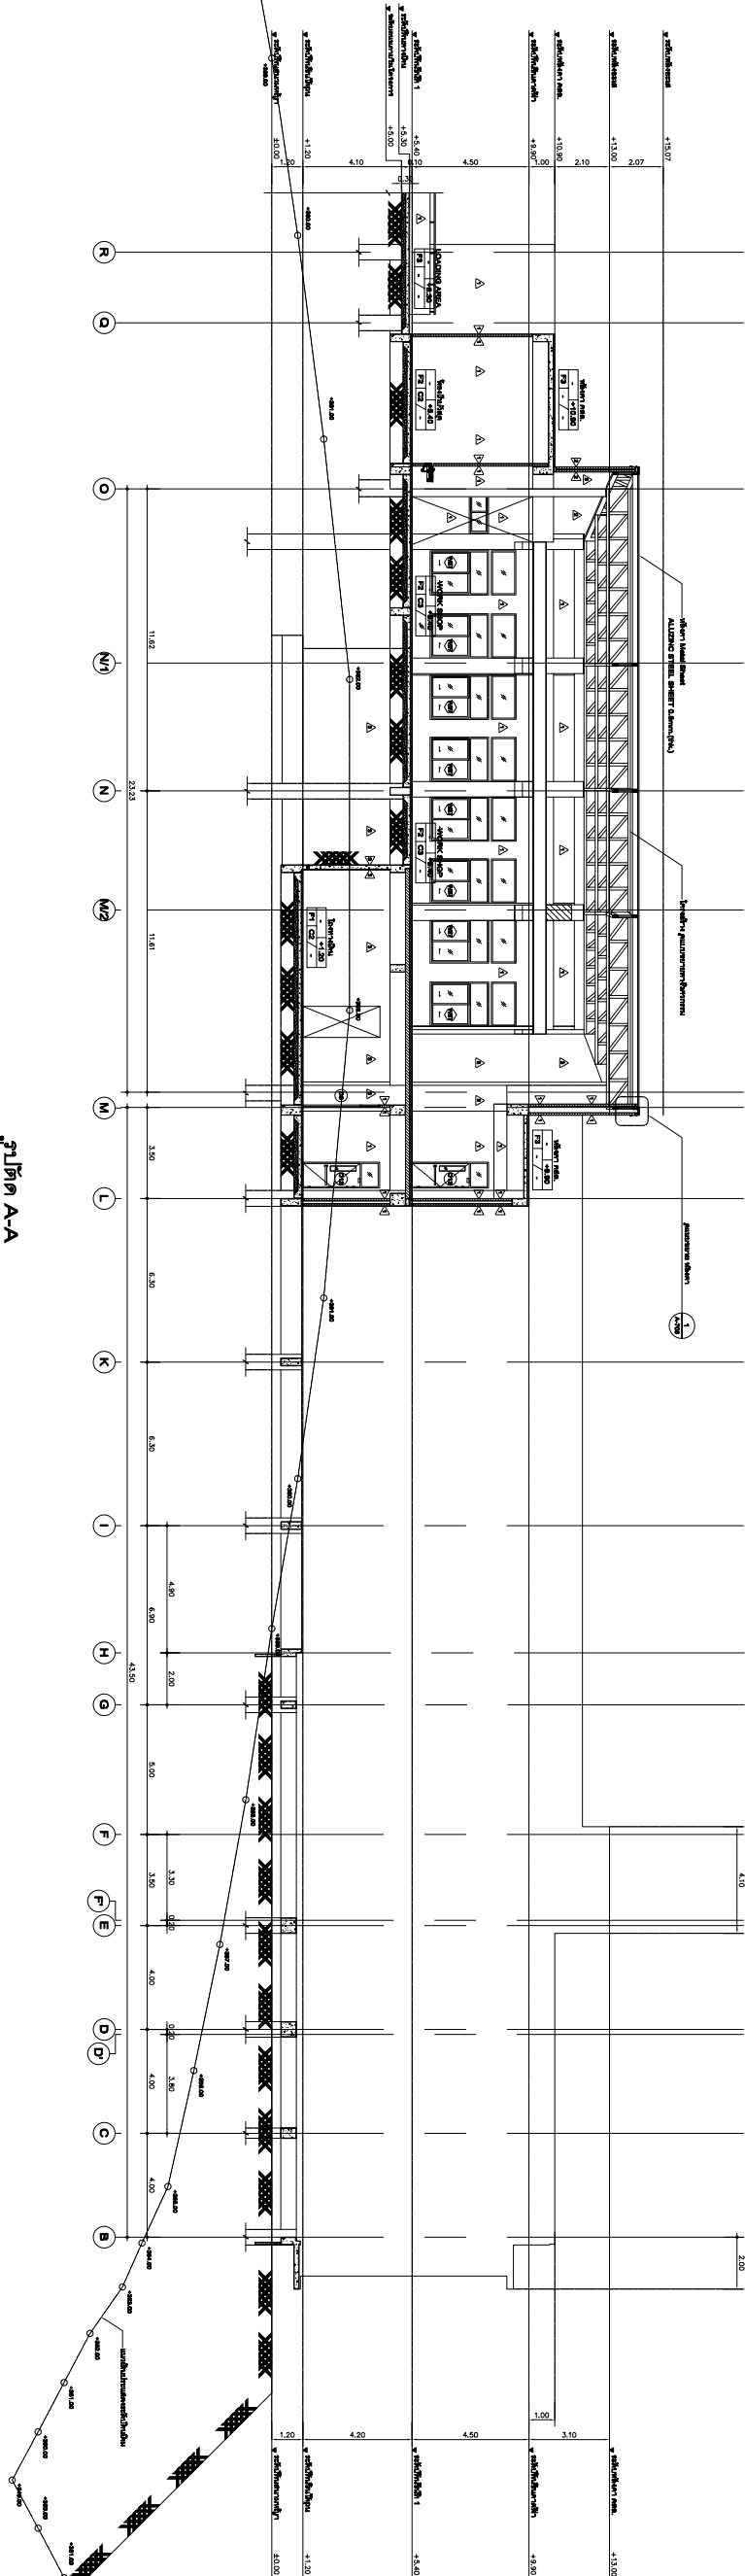

A-A
 1:100

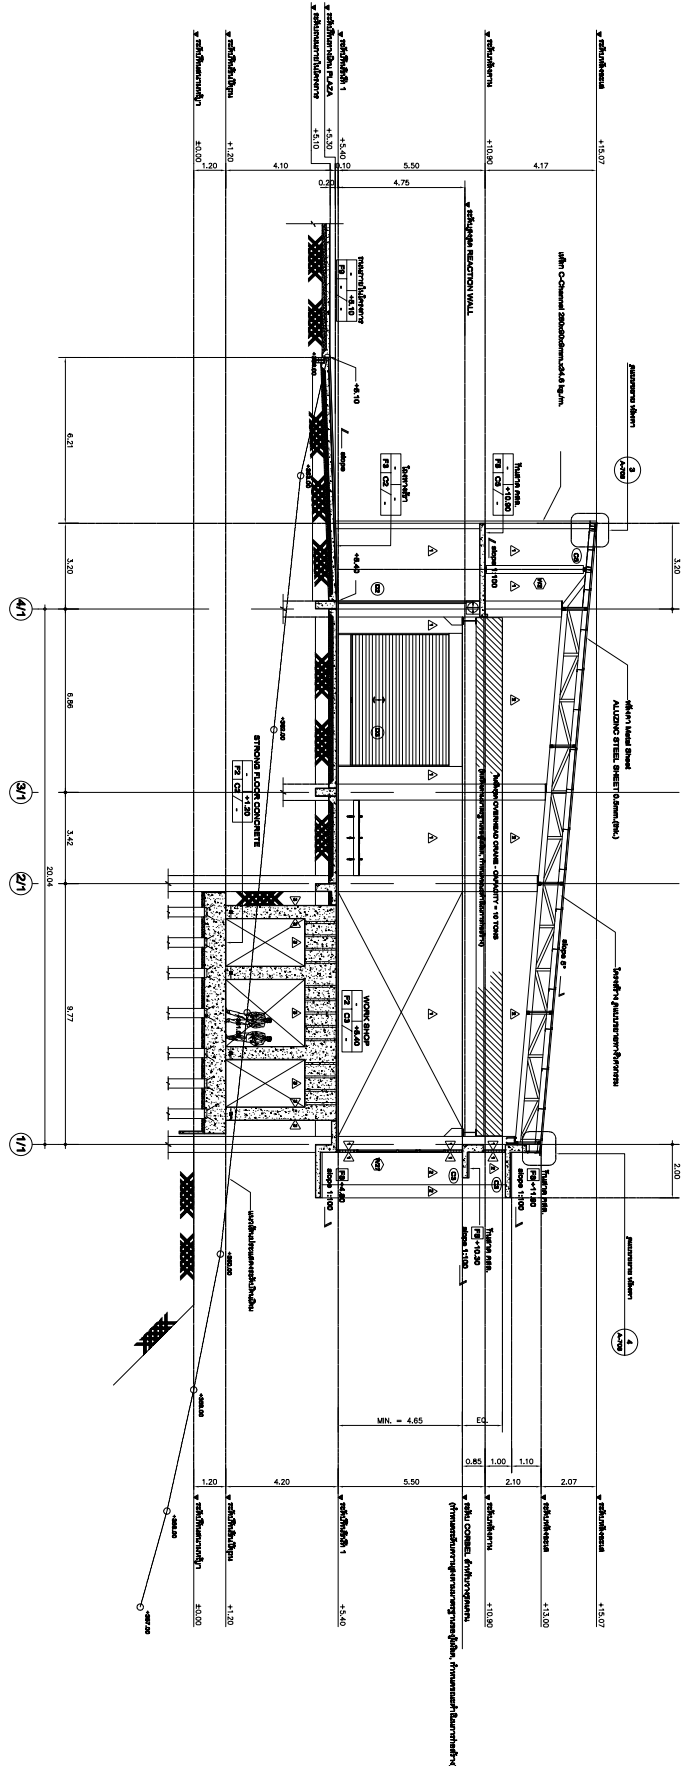

B-B
 1:100

[illegible]

**Planning
Architectural Design
Project Consultant
Construction Management**

300/27-28 Moo 1, Tambol Maeheua, Muang, Chiangmai 50100 Thailand
Tel: +66 (0) 5380 4671 Fax: +66 (0) 5380 4672
E-mail: axisgroup1994@gmail.com

[illegible]

Architect	Working drawings	2025.1.11	Approved Signature 
	Contract Documents	2025.1.10	
	Field Notes	2025.1.12	Approved Signature 
	Site Photos	2025.1.12	
Structural Engineer	Foundation Design	2025.1.12	Approved Signature 
	Column Design	2025.1.12	
Electrical Engineer	General Layout	2025.1.12	Approved Signature 
	Panel Schedules	2025.1.12	
Sanitary Engineer	Plumbing Fixtures	2025.1.12	Approved Signature 
	Water Supply	2025.1.12	
Mechanical Engineer	Heating, Ventilation, and Air Conditioning	2025.1.12	Approved Signature 
	Refrigeration	2025.1.12	
Interior Design	Furniture Layout	2025.1.12	Approved Signature 
	Material Selection	2025.1.12	
Landscape Design	Site Plan	2025.1.12	Approved Signature 
	Planting Schedule	2025.1.12	
Drawn By	Project Manager	2025.1.12	Approved Signature 
	Architect	2025.1.12	
Printed Date	Drawing No.	A-402 / 29	Drawing No.
	Sheet No.	29	
Ref. File	File Name	2025.1.12	File Name
	File Path	2025.1.12	

Owner

Jeffrey M. Mowbray, Director of Public

Project Name

စာအုပ်အမျိုးအမည်

Drawing Title

WORKING WITH THE FUTURE OF WORK

[illegible]

Axigsgroup
Co.,Ltd.

**Planning
Architectural Design
Project Consultant
Construction Management**

30027-28 Moo 1, Tambon Maekham, Muang, Chiangmai 50100 Thailand
Tel : +66 (0) 530 4671 Fax : +66 (0) 5300 4672
E-mail : satagunp1984@gmail.com

[illegible]

30027-28 Moo 1, Tambol Maethan, Muang, Chongmai 60100 Thailand
Tel: +66 (0) 5360 4671 Fax: +66 (0) 5360 4672
E-mail: aridgroup1894@gmail.com

Architect	 John Smith john.smith 123.456 789.012 123.456 789.012 123.456	060.111 123.456 789.012
Structural Engineer	 Jane Doe jane.doe 987.654 321.098 987.654 321.098 987.654	060.111 123.456 789.012
Electrical Engineer	 Bob Johnson bob.johnson 654.321 098.765 654.321 098.765 654.321	060.111 123.456 789.012
Mechanical Engineer	 Alice Williams alice.williams 543.210 987.654 543.210 987.654 543.210	060.111 123.456 789.012
Interior Design	 Charlie Brown charlie.brown 432.109 876.543 432.109 876.543 432.109	060.111 123.456 789.012
Landscape Design	 Diana Prince diana.prince 321.098 765.432 321.098 765.432 321.098	060.111 123.456 789.012
Drawn By	 Eddy Platter eddy.platter 210.987 654.321 210.987 654.321 210.987	060.111 123.456 789.012
Printed Date	A-604 129 060.111 123.456 789.012	060.111 123.456 789.012
Ref. File	A-604 129 060.111 123.456 789.012	060.111 123.456 789.012

Owner

સાવિત્રીબાઈ પટેલ ગ્રામીણ સેવકોનાર

Project Name

การดำเนินงานตามแผนปฏิบัติการ

Drawing Title

[illegible]

Axigroup
Co.,Ltd.

**Planning
Architectural Design
Project Consultant
Construction Management**

30027-28 Moo 1, Tambol Maetham, Muang, Chiangrai 60100 Thailand
Tel: +66 (0) 5380 4671 Fax: +66 (0) 5380 4672
E-mail: auisgroup1994@gmail.com

[illegible]

Drawing Title

[illegible][illegible]

Axisgroup

Co., Ltd

**Planning
Architectural Design
Project Consultant
Construction Management**

30027-28 Moo 1, Tambol Muehna, Muang, Chongnaburi 60100 Thailand
Tel: +66 (0) 5380 4671 Fax: +66 (0) 5380 4672
E-mail: asidgroup1894@gmail.com

Architect	John Smith	Rev. 1.1	Authorized Signature	
Project Manager	Jane Doe	Rev. 1.2	Authorized Signature	
Structural Engineer	John Smith	Rev. 1.3	Authorized Signature	
Electrical Engineer	John Smith	Rev. 1.4	Authorized Signature	
Mechanical Engineer	John Smith	Rev. 1.5	Authorized Signature	
Interior Design	John Smith	Rev. 1.6	Authorized Signature	
Landscaping Design	John Smith	Rev. 1.7	Authorized Signature	
Drawn By	John Smith	Rev. 1.8	Authorized Signature	
Printed Date	John Smith	Rev. 1.9	Authorized Signature	
Ref. File	John Smith	Rev. 1.10	Authorized Signature	

OWNER

00000000000000000000

Project Name

00000000000000000000

Drawing Title

Issue/Revision	
Description	Date


Axisgroup

Co., Ltd.


Planning
Architectural Design
Project Consultant
Construction Management

2022.08.10 Mon. 1. 10:00 AM (Mon. 10:00 AM) 10:00 AM
Tel : +82 (0) 2000-0000 Fax : +82 (0) 2000-0000
Email : 0000000000@axisgroup.com


지붕면 1
1:500

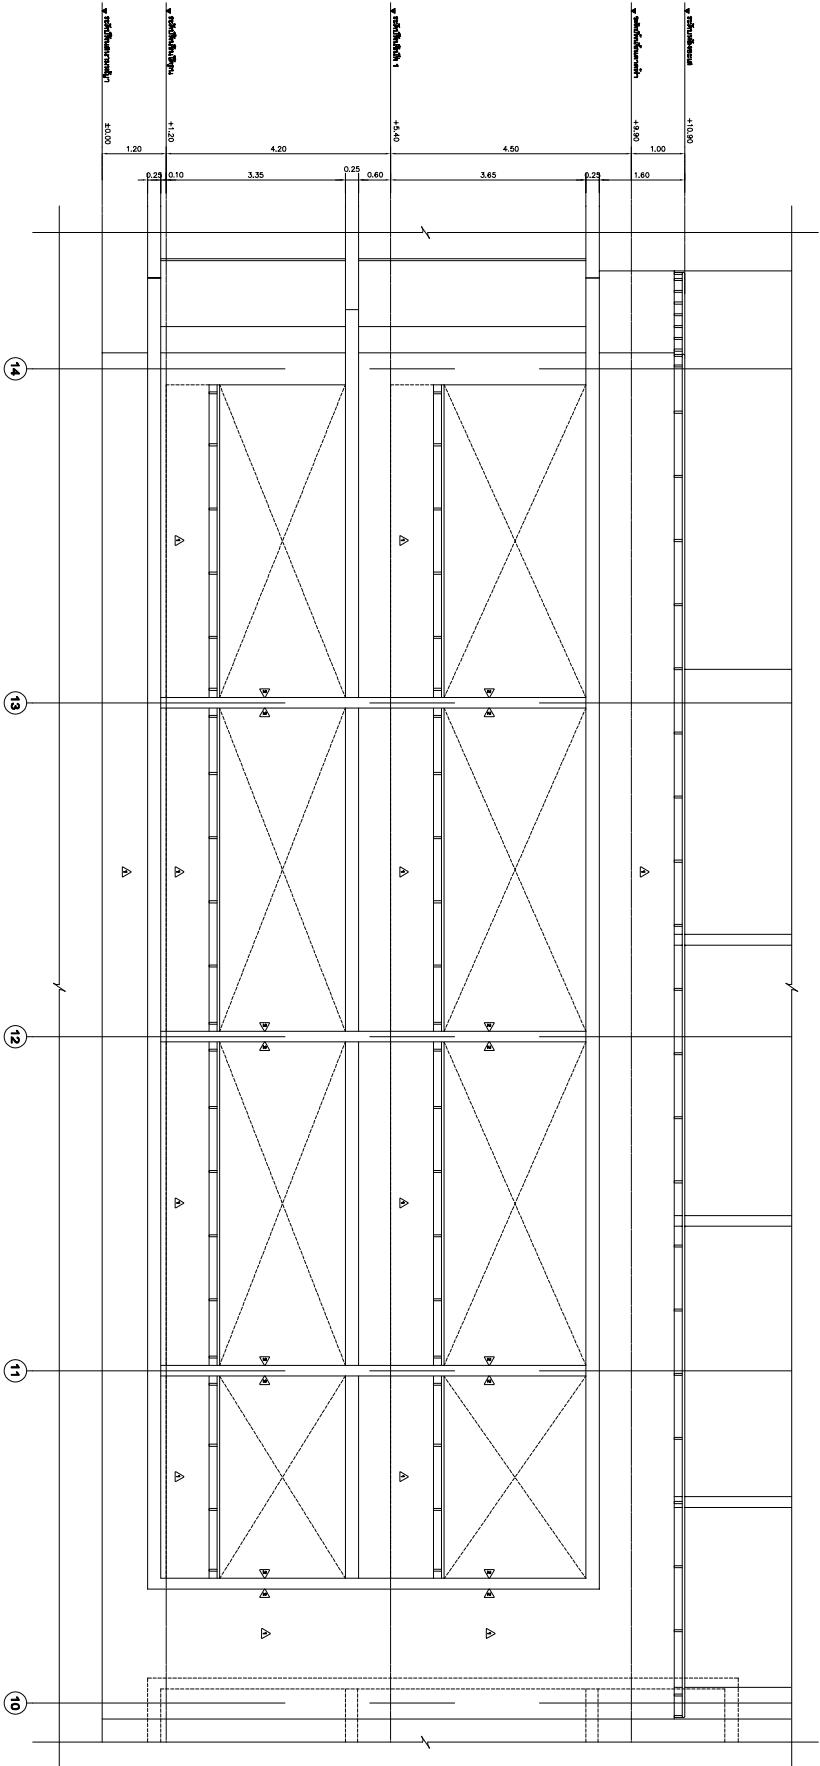

지붕면 2
1:500

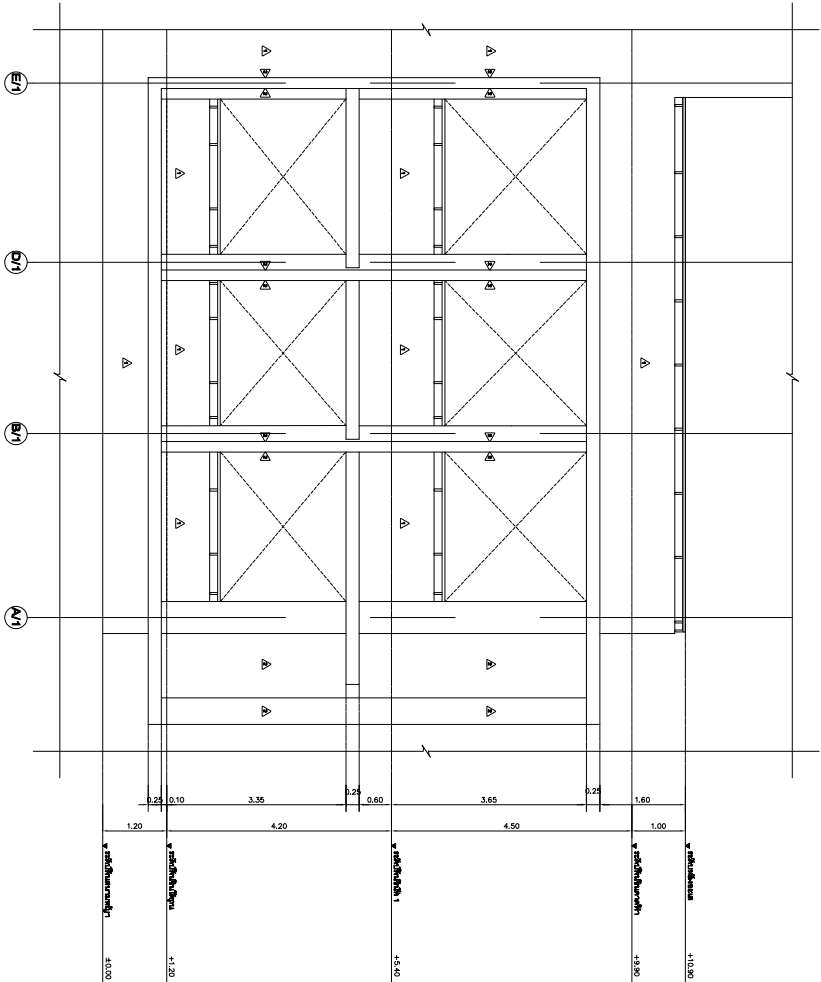

지붕면 A-A
1:500

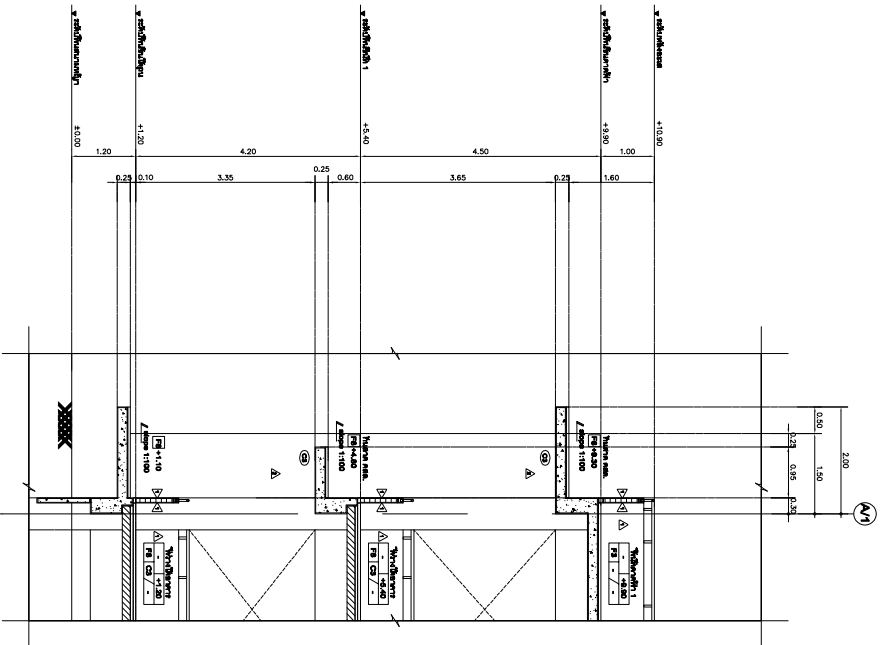

Architect	000-000-0000	000-000-0000
Architectural Designer	000-000-0000	000-000-0000
Structural Engineer	000-000-0000	000-000-0000
Electrical Engineer	000-000-0000	000-000-0000
Mechanical Engineer	000-000-0000	000-000-0000
Sanitary Engineer	000-000-0000	000-000-0000
Interior Designer	000-000-0000	000-000-0000
Landscape Designer	000-000-0000	000-000-0000
Drawn By	000-000-0000	000-000-0000
Printed Date	000-000-0000	000-000-0000
Ref. File	000-000-0000	000-000-0000

Owner

Project Name

Drawing Title

Issue/Revision
1
2
3
100

[illegible]

Co., Ltd

Construction Management

E-mail : edigroup1984@gmail.com

Architect	Authorized Signature
info@mcw.edu	<i>[Signature]</i>
prof@mcw.edu	<i>[Signature]</i>
mcw.edu	mcw.edu
50555 Birch	50555 Birch
Phone: (408) 281-1725	<i>[Signature]</i>

Structural Engineer		Authorized Signature
Team Lead/Engineer	an. 0015	
m/Team member	m/001725	
Electrical Engineer		Authorized Signature
engineer Job	enr. 000	
V&A, Safety	m/001444	
Project Management	m/001875	

Sanitary Engineer	Authorized Signature
John Arrington	
Oct. 73	

Mechanical Engineer	Authorized Signature
Todd W. Hruschka	
Regist. no.	PA 14228
expir. expires	PA 2008
	Unit - None


Interior Design	Authorized Signature
-----------------	----------------------

Landscape Design	Authorized Signature
Printed Name	Date

Drawn By	Authorized Signature
Theresa Vershn	

Printed Date	Drawing No.
	A-704 /29

Ref. File	Date
-----------	------

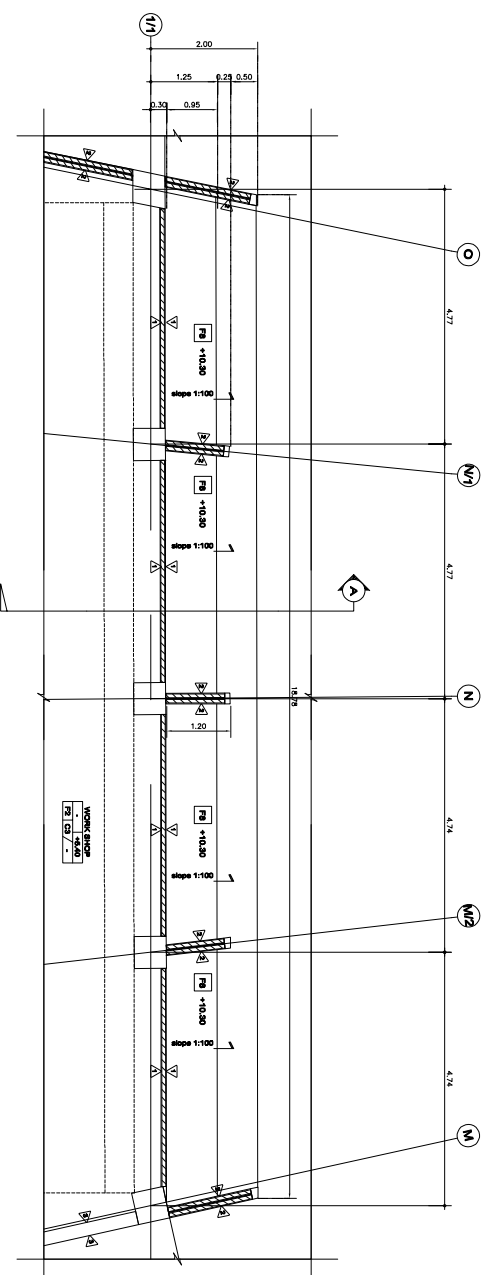


8CALL



SCALE



 2008



1000

[illegible]

OWNER

บริษัท อซิสกรุป จำกัด

Project Name

โครงการพัฒนาระบบชลประทาน

Drawing Title

Issue/Revision	Date
Description	

Axisgroup
Co., Ltd.

Planning
Architectural Design
Project Consultant
Construction Management

2023/01/01 - 2023/01/01
No. 1/2023/01/01 Rev. 1/2023/01/01
Email: info@axisgroup.co.th

2023/01/01 - 2023/01/01
No. 1/2023/01/01 Rev. 1/2023/01/01
Email: info@axisgroup.co.th

Drawn By	Authorised Signature
Checked By	Authorised Signature
Printed Date	Drawing No.
Ref. File	Date

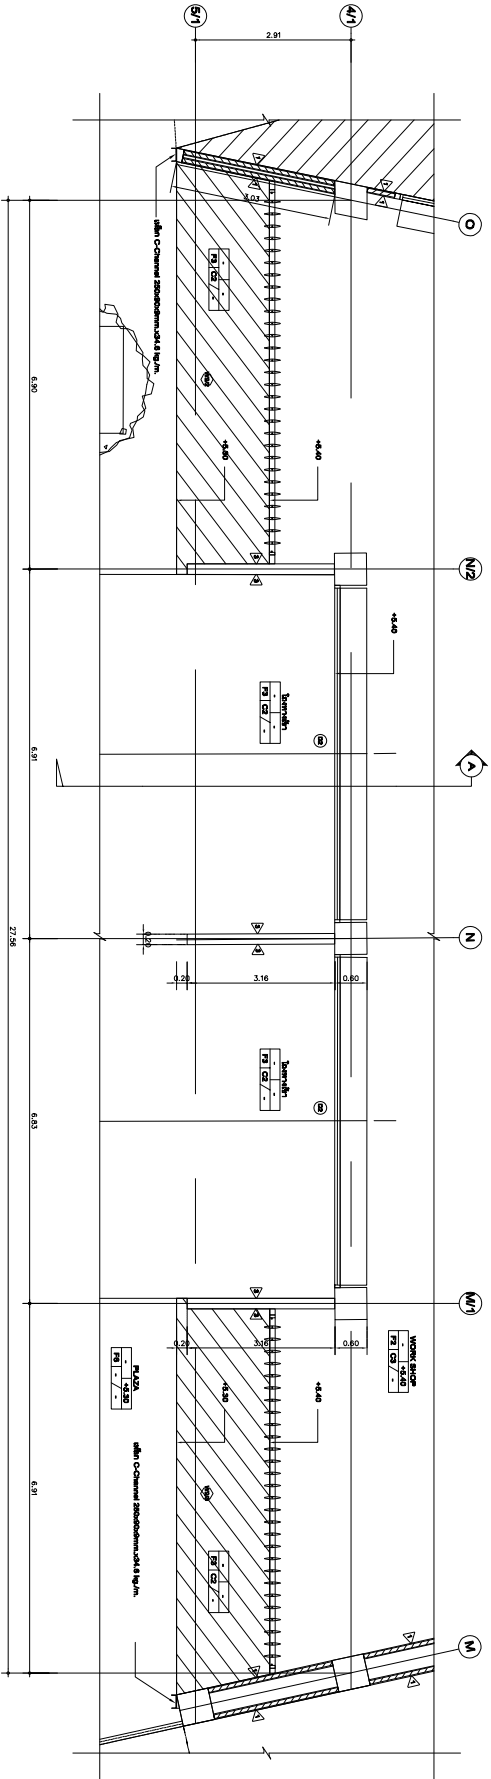

แปลนขยายประตู 2 ชั้นหลังคา คสล.

SCALE

 
1:100

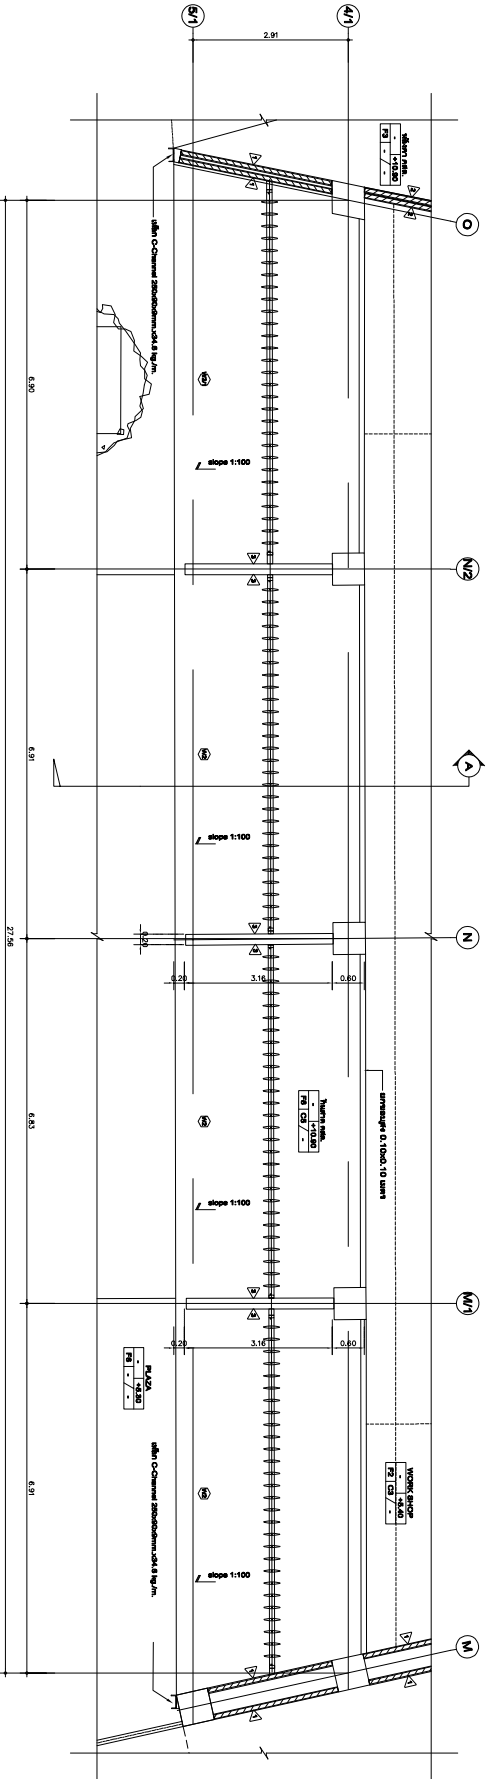

แปลนขยายประตู 2 ชั้นหลังคา คสล.

SCALE

1:100

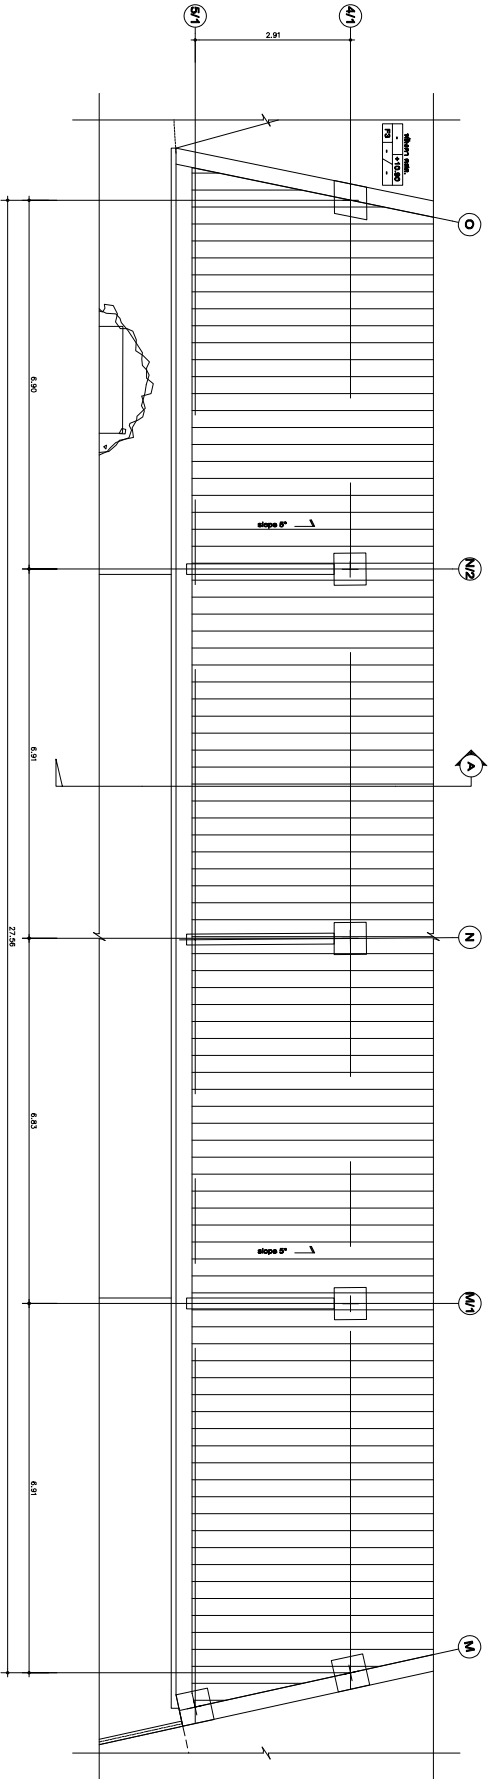

แปลนขยายประตู 2 ชั้นหลังคา คสล.

SCALE

1:100



OWNER

00000000000000000000

Project Name

00000000000000000000

Drawing Title



Issue/Revision	
Description	Date

Axisgroup
Co., Ltd.

Planning
Architectural Design
Project Consultant
Construction Management

2023/11/01
No. 1/2023/00000000000000000000
Email: 00000000000000000000

รูปตัด 1
1:50

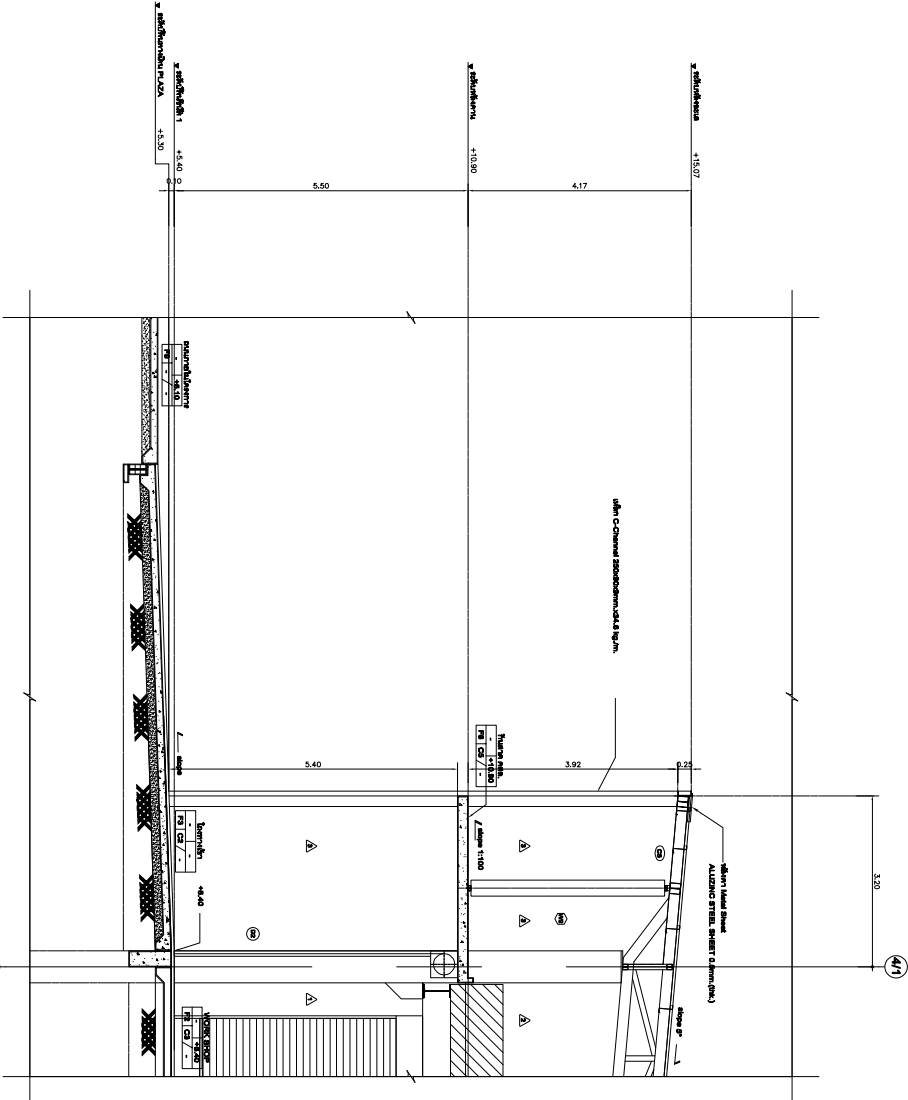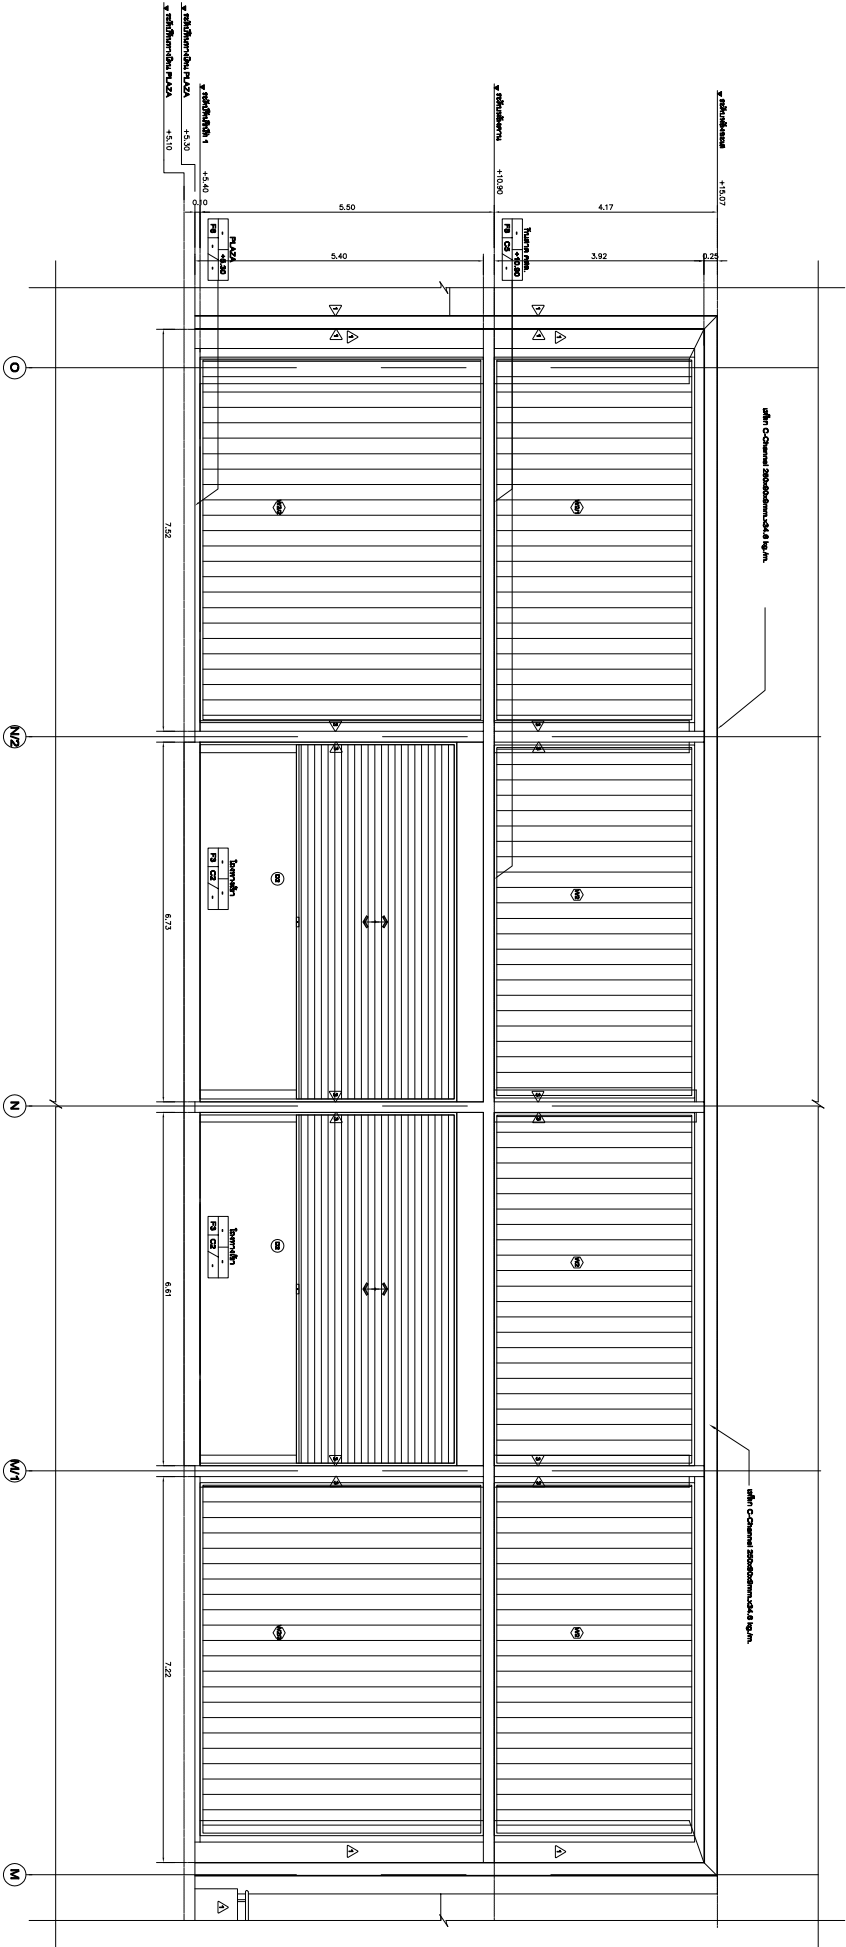

รูปตัด A-A
1:50

Ref. File	Date
-----------	------

Drawn By	Authorized Signature

Printed Date	Drawing No.
--------------	-------------

	A-706 /29
--	-----------

